

1 2 3 4 5 6 7 8 9

- NOTES:**
- SYMBOLS LEGEND
- SPRINKLER HEAD
 - ⊕ SMOKE DETECTOR
 - ⊕ GFCI - GROUND FAULT INTERRUPTER
 - ⊕ RECEPTACLE
 - ⊕ SWITCH
 - ▽ TS/STAT
 - SURFACE MTD. LIGHT FIXTURE
 - WALL SCONCE
 - HVAC REGISTER

EXISTING BUILDING NOTES:

1) DIMENSIONS SHOWN ARE FROM OWNERS PROVIDED SURVEY. ROOM DIMENSIONS SHOWN ARE FIELD MEASURED TO INSIDE OF WALLS AND ARE TO BE USED SOLELY FOR THE BASIS OF INTERIOR DESIGNS.

2) BUILDINGS 500, 600, 700 & 800 ARE NOT SPRINKLERED. SMOKE DETECTORS ARE EXISTING.

3) DOORS: ALL DOORS ARE HOLLOW CORE WOOD FLUSH. STAINED. BASE WOOD STAINED.

4) FINISHES: FLOORING IS CARPET UNLESS NOTED OTHERWISE. WALLS & CEILING ARE PAINTED UNLESS OTHERWISE NOTED

5) TUBS: SUPPORDUNS UNLESS OTHERWISE NOTED.

| REV. | DATE | ISSUE HISTORY |
|------|------------|---------------|
| △ | 04-06-2018 | PROGRESS 75% |
| | | |
| | | |
| | | |
| | | |

THOMAS BROWN ARCHITECT

TBA

5268 PINTO WAY ORLANDO, FLORIDA, 32810
407-256-6990 www.thomasbrownarchitect.com

INTERIOR DESIGN

MEASURED DRAWINGS

BARRIER ISLAND STATION
1245 DUCK ROAD
DUCK, NO. CAROLINA

BLDG. 800.1, 800.2 & 800.3
EXIST. 1st, 2nd & 3RD FLOOR PLANS

PROJECT # 031618

DATE: 04/01/18


DESIGNER: JFS

DRAWN BY: TB

SCALE: 1/4" = 1'-0"

A8.00

THOMAS H. BROWN, JR.
NORTH CAROLINA ARCHITECTS LICENSE #13995

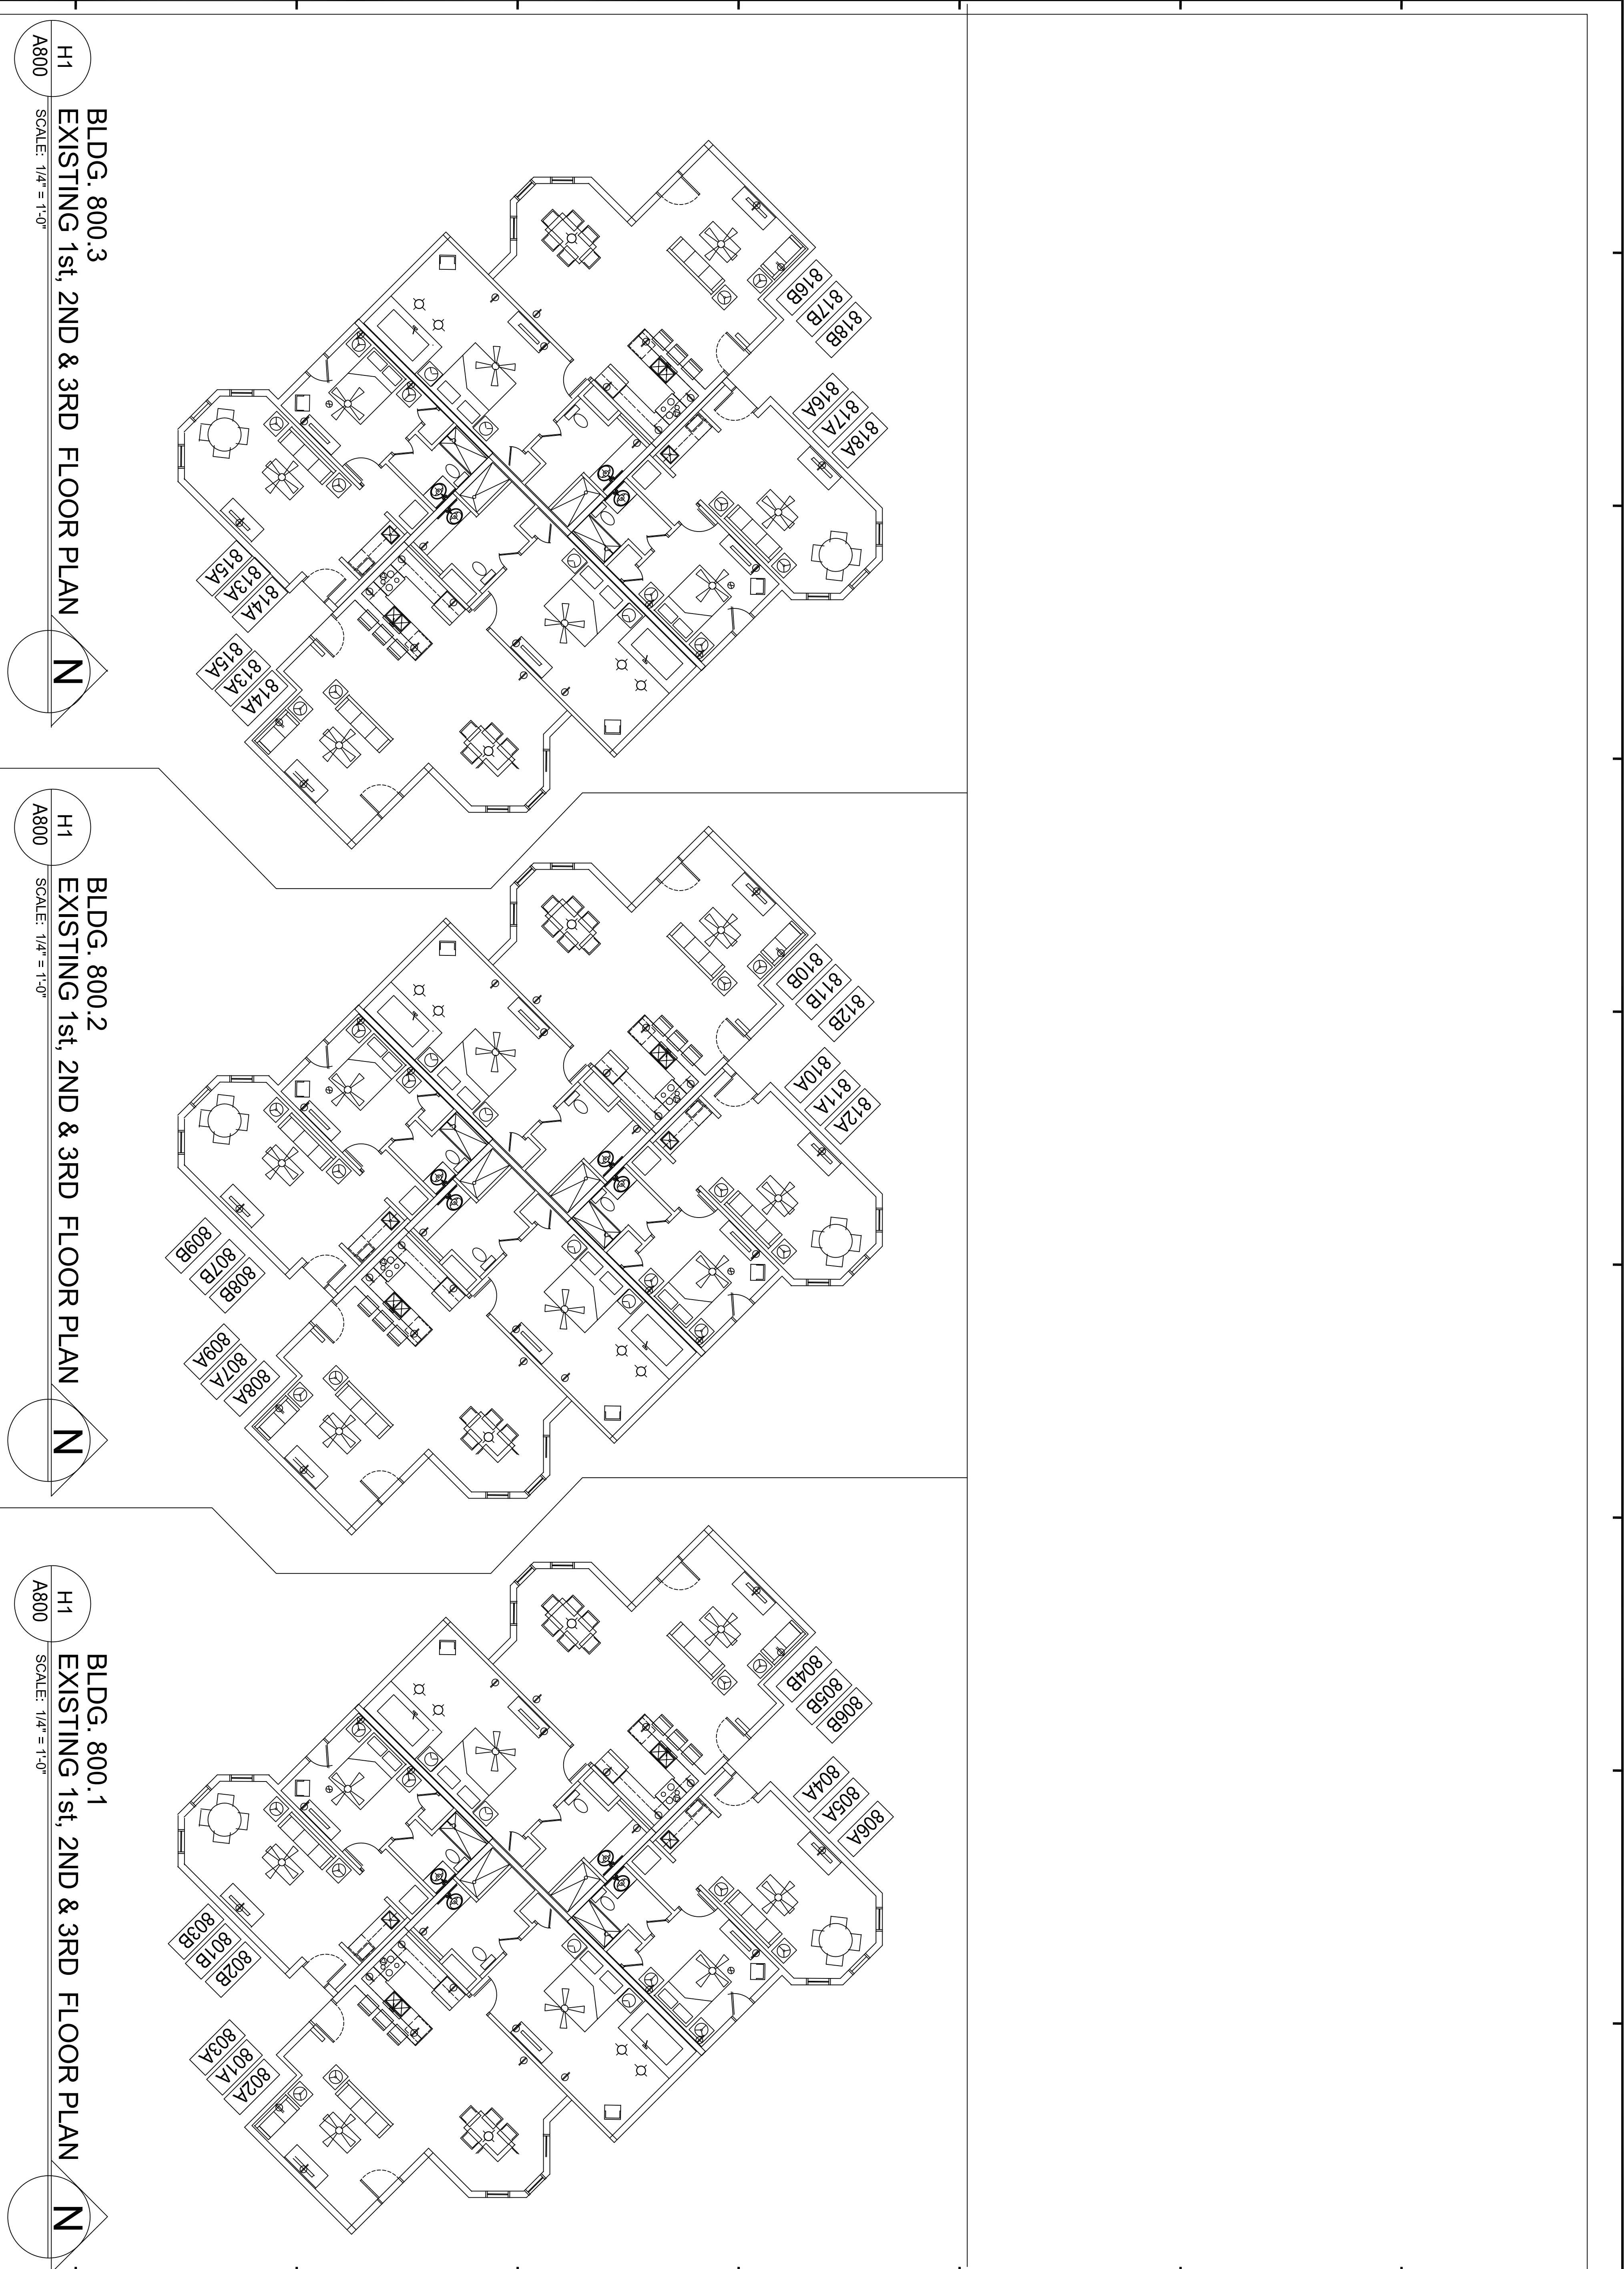

BLDG. 800.3
EXISTING 1st, 2ND & 3RD FLOOR PLAN

SCALE: 1/4" = 1'-0"

H1 A800

BLDG. 800.2
EXISTING 1st, 2ND & 3RD FLOOR PLAN

SCALE: 1/4" = 1'-0"

H1 A800

BLDG. 800.1
EXISTING 1st, 2ND & 3RD FLOOR PLAN

SCALE: 1/4" = 1'-0"

H1 A800